


REMODEL OF EXISTING RESTAURANT

Barbacoa MEXICAN GRILL
1030 Glendon Avenue
Westwood, CA 90024

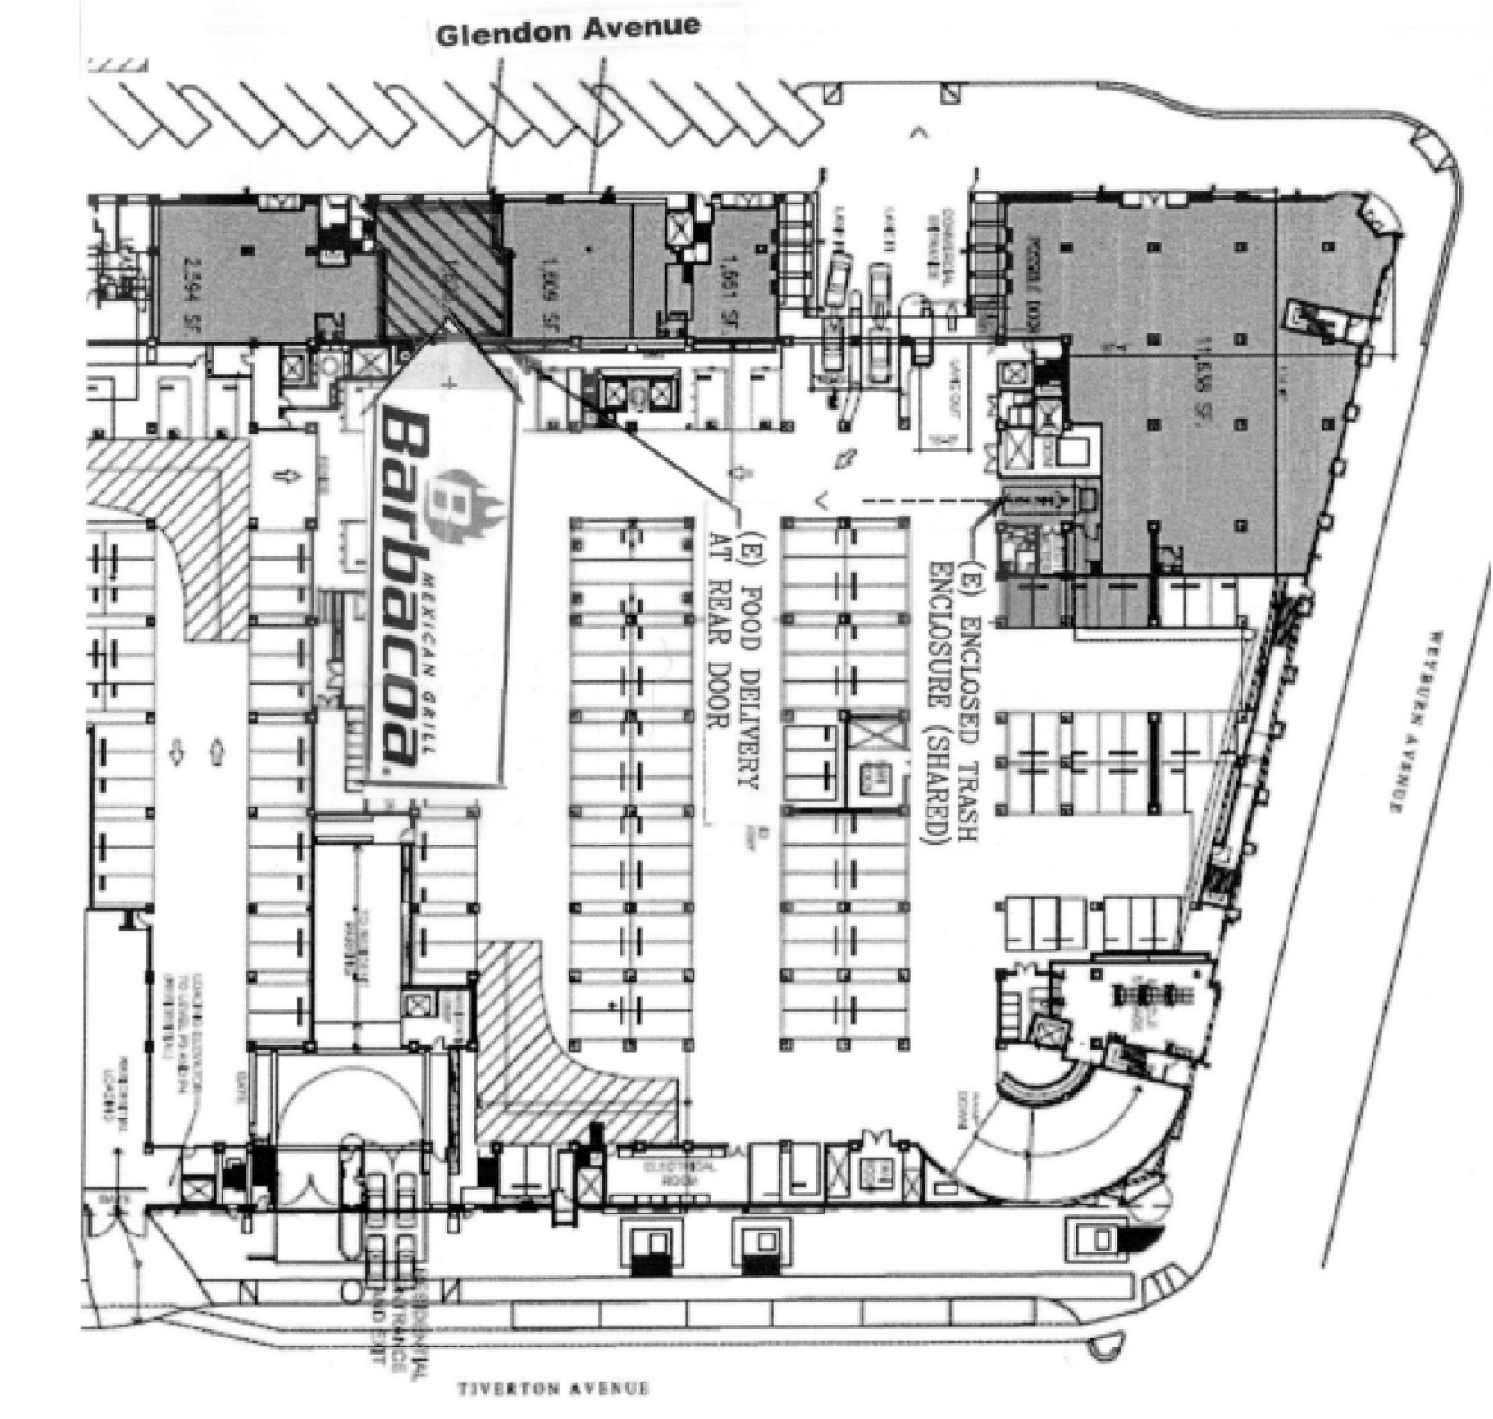


OVERALL BUILDING SITE PLAN

SCALE: NONE


PROJECT SCOPE

- REMODEL OF EXISTING "PASTAGNA" RESTAURANT. 1680 SQ. FT.
- REPLACE EXISTING TYPE-1 RECIRCULATING HOOD SYSTEM WITH NEW TYPE-1 HOOD SYSTEM THAT DISCHARGES TO ATMOSPHERE INCLUDING A MAKE-UP AIR SYSTEM ELECTRICALLY INTERLOCKED WITH THE EXHAUST FAN. AMOUNT OF MAKE-UP AIR EQUALS THE EXHAUST AIR QUANTITY.
- NO CHANGE IN SANITARY FACILITIES.
- NO CHANGE IN NUMBER OF PLUMBING FIXTURE UNITS.
- NO CHANGE IN OCCUPANCY AND NUMBER OF TOILET FIXTURES.
- NO CHANGE IN GREASE WASTE SYSTEM. EXISTING KITCHEN FIXTURES PLANNED TO EXISTING GREASE INTERCEPTOR LOCATED IN BASEMENT.
- NO CHANGE IN USE, AND NO CHANGE IN PARKING REQUIREMENT.

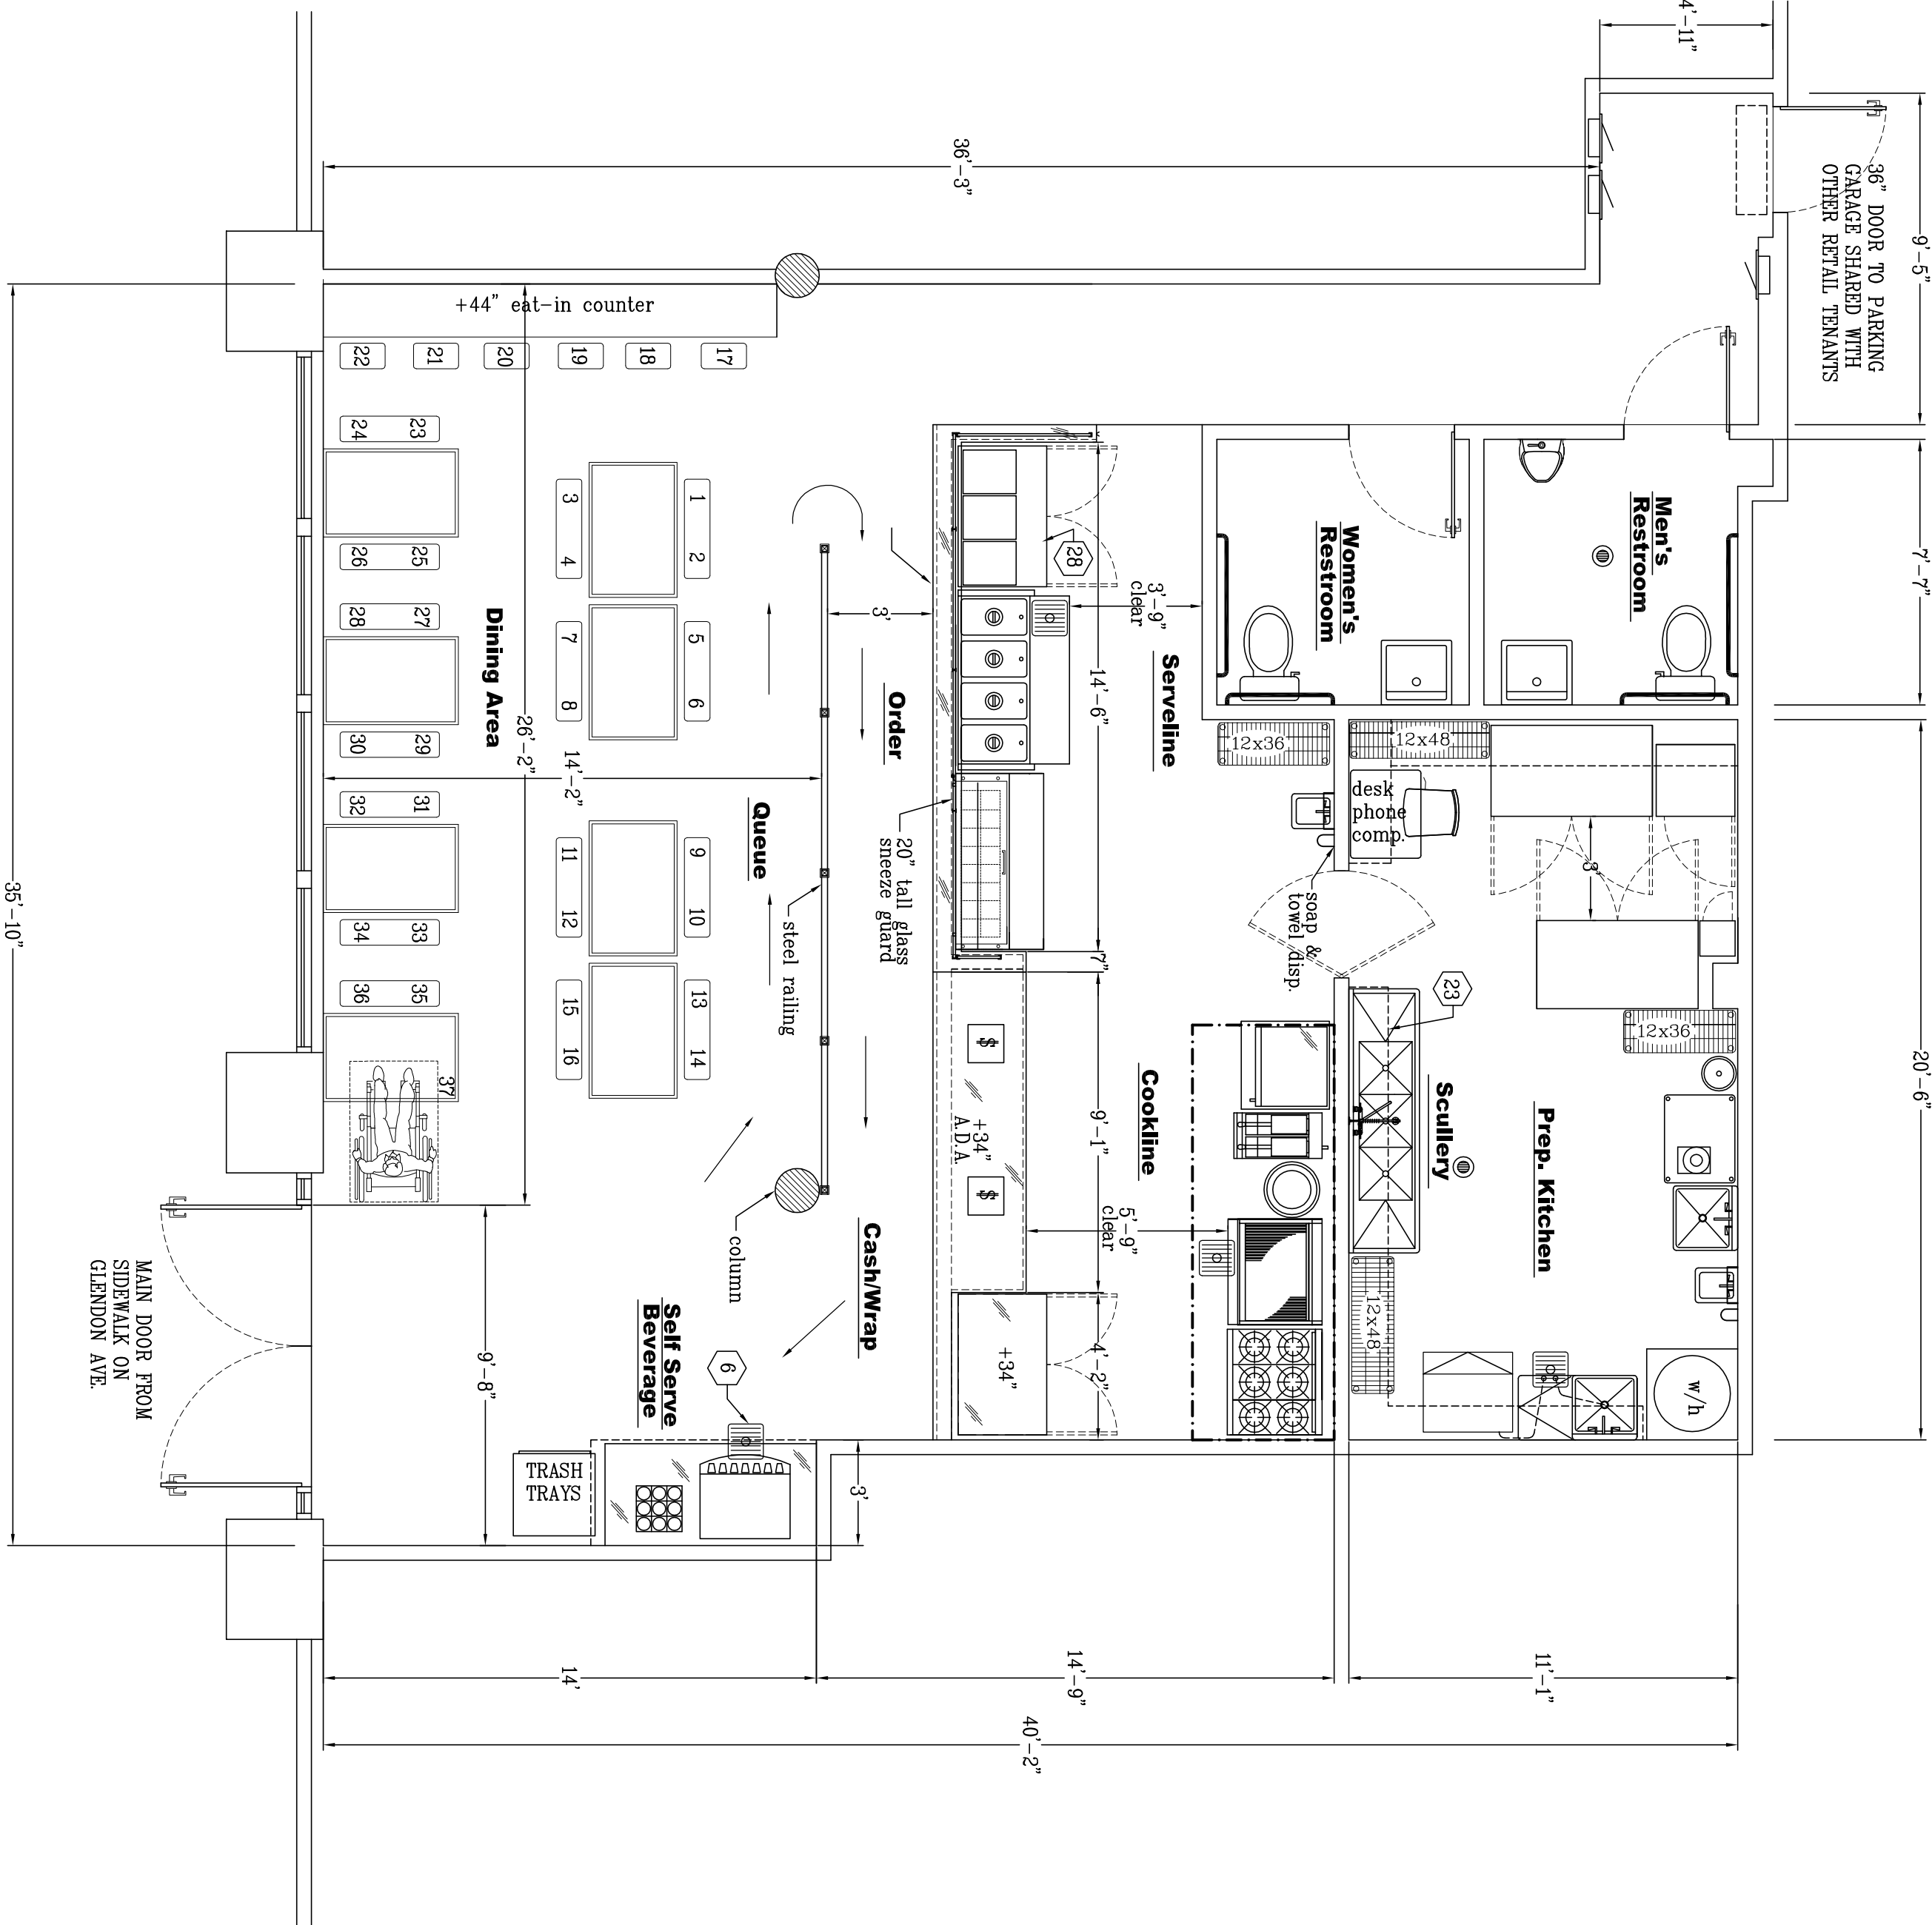

RESTAURANT FLOOR PLAN

SCALE: 1/4" = 1'-0"

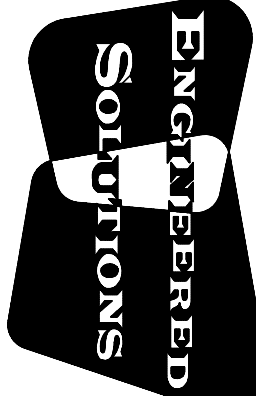

Construction Design

23679 Calabasas Rd. #678
Calabasas, CA 91302
Ph: 818.516.6992
fx: 818.880.0104
pollifonguy@aol.com

Salahaldin Construction

3130 E. Willow Street
Signal Hill, California 90750
Ph: 562.304.8899
Cal Lic # B-919996

No.	Description	Date

Barbacoa MEXICAN GRILL
1030 Glendon Avenue
Westwood, CA 90024

TYPE - 1 HOOD REPLACEMENT
HEALTH DEPT. NOTES
EQUIPMENT PLAN
EQUIPMENT SCHEDULE
FINISH SCHEDULE

Start Date	5/20/13
Drawn	dk
Checked	nk
Proj. No.	13-005
Scale	shown

Drawing No.

ABC-1